
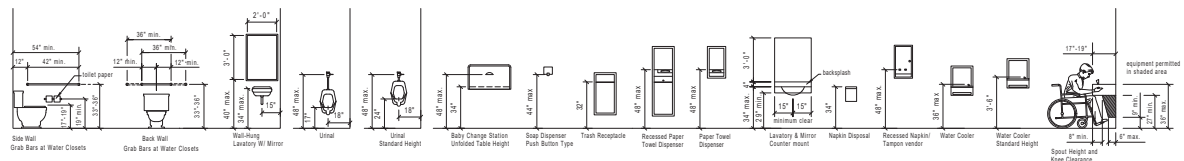


② STOREFRONT LEFT
3/8" = 1'-0"

③ **STOREFRONT RIGHT**

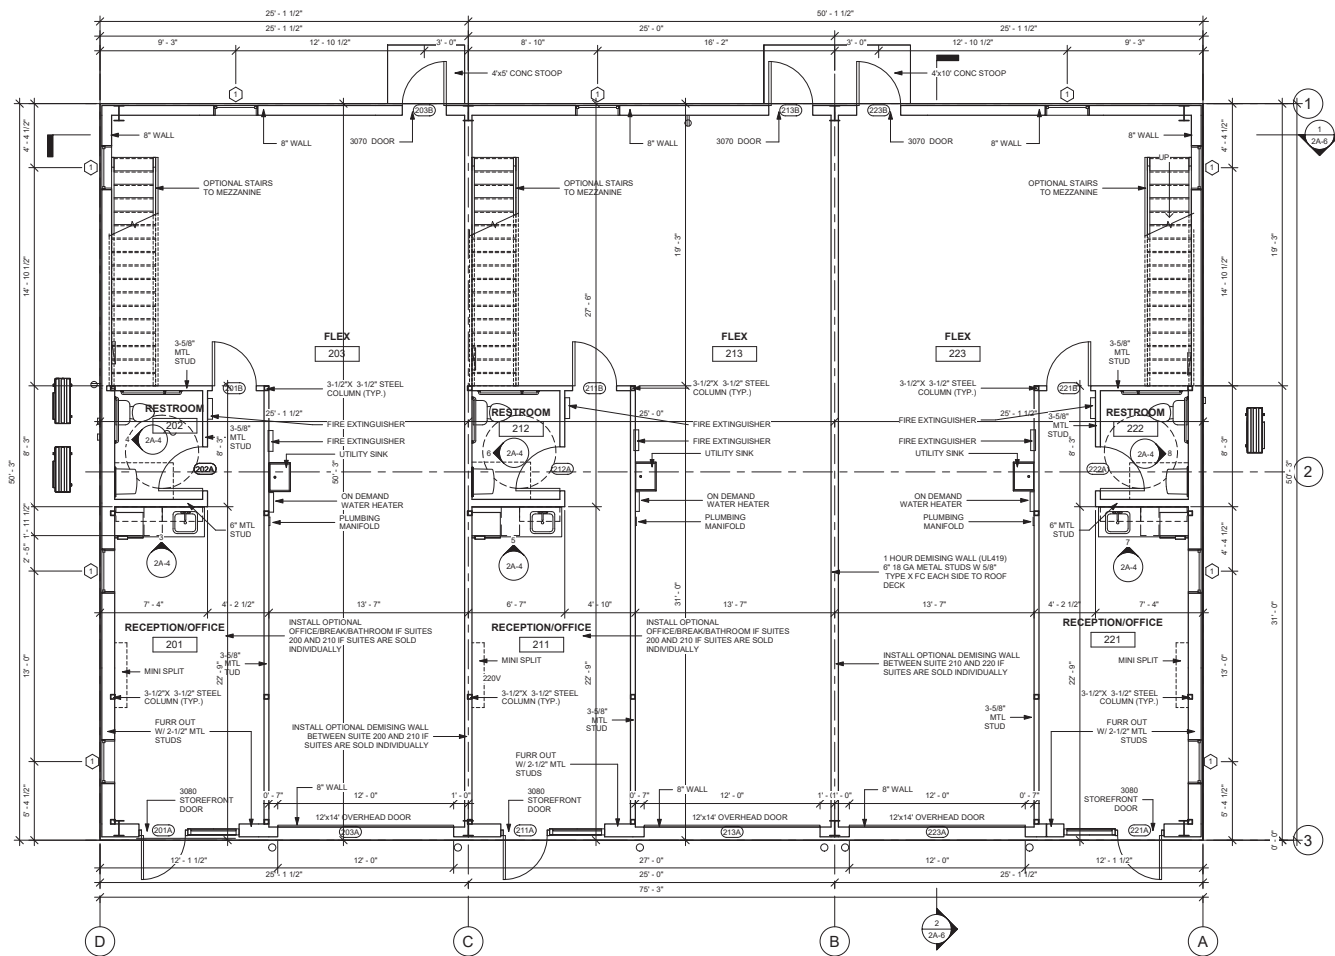

FIXTURE MOUNTING HEIGHTS FOR THE DISABLED (ADA)

① FINISH FLOOR
1/4" = 1'-0"

NOTE:

- 1- ALL INTERIOR DOORS TO BE 36"x84"
- 2- CONSTRUCTION TYPE IIB (2015 IBC)
- 3- ALL DOOR HARDWARE TO BE ACCESSIBLE COMPLIANT.
- 4- ALL PLUMBING FIXTURES TO BE ACCESSIBLE COMPLIANT
- 5- ALL DOOR DOORS TO FITTED WITH LEVER HANDLES THAT MEET ACCESSIBILITY REQUIREMENTS.
- 6-GC TO INSTALL SOAP DISPENSER AND PAPER TOWEL DISPENSER IN RESTROOM TO MEET ADA REQUIREMENTS

[illegible]

WORKSPACE USA

PHASE 3

BUILDING 2
FLOOR PLAN

Project number	2025-05
----------------	---------

Date	03-18-2025
------	------------

Drawn by	JS
----------	----

Checked by	JS
------------	----

2A-1

Scale	As indicated
-------	--------------